

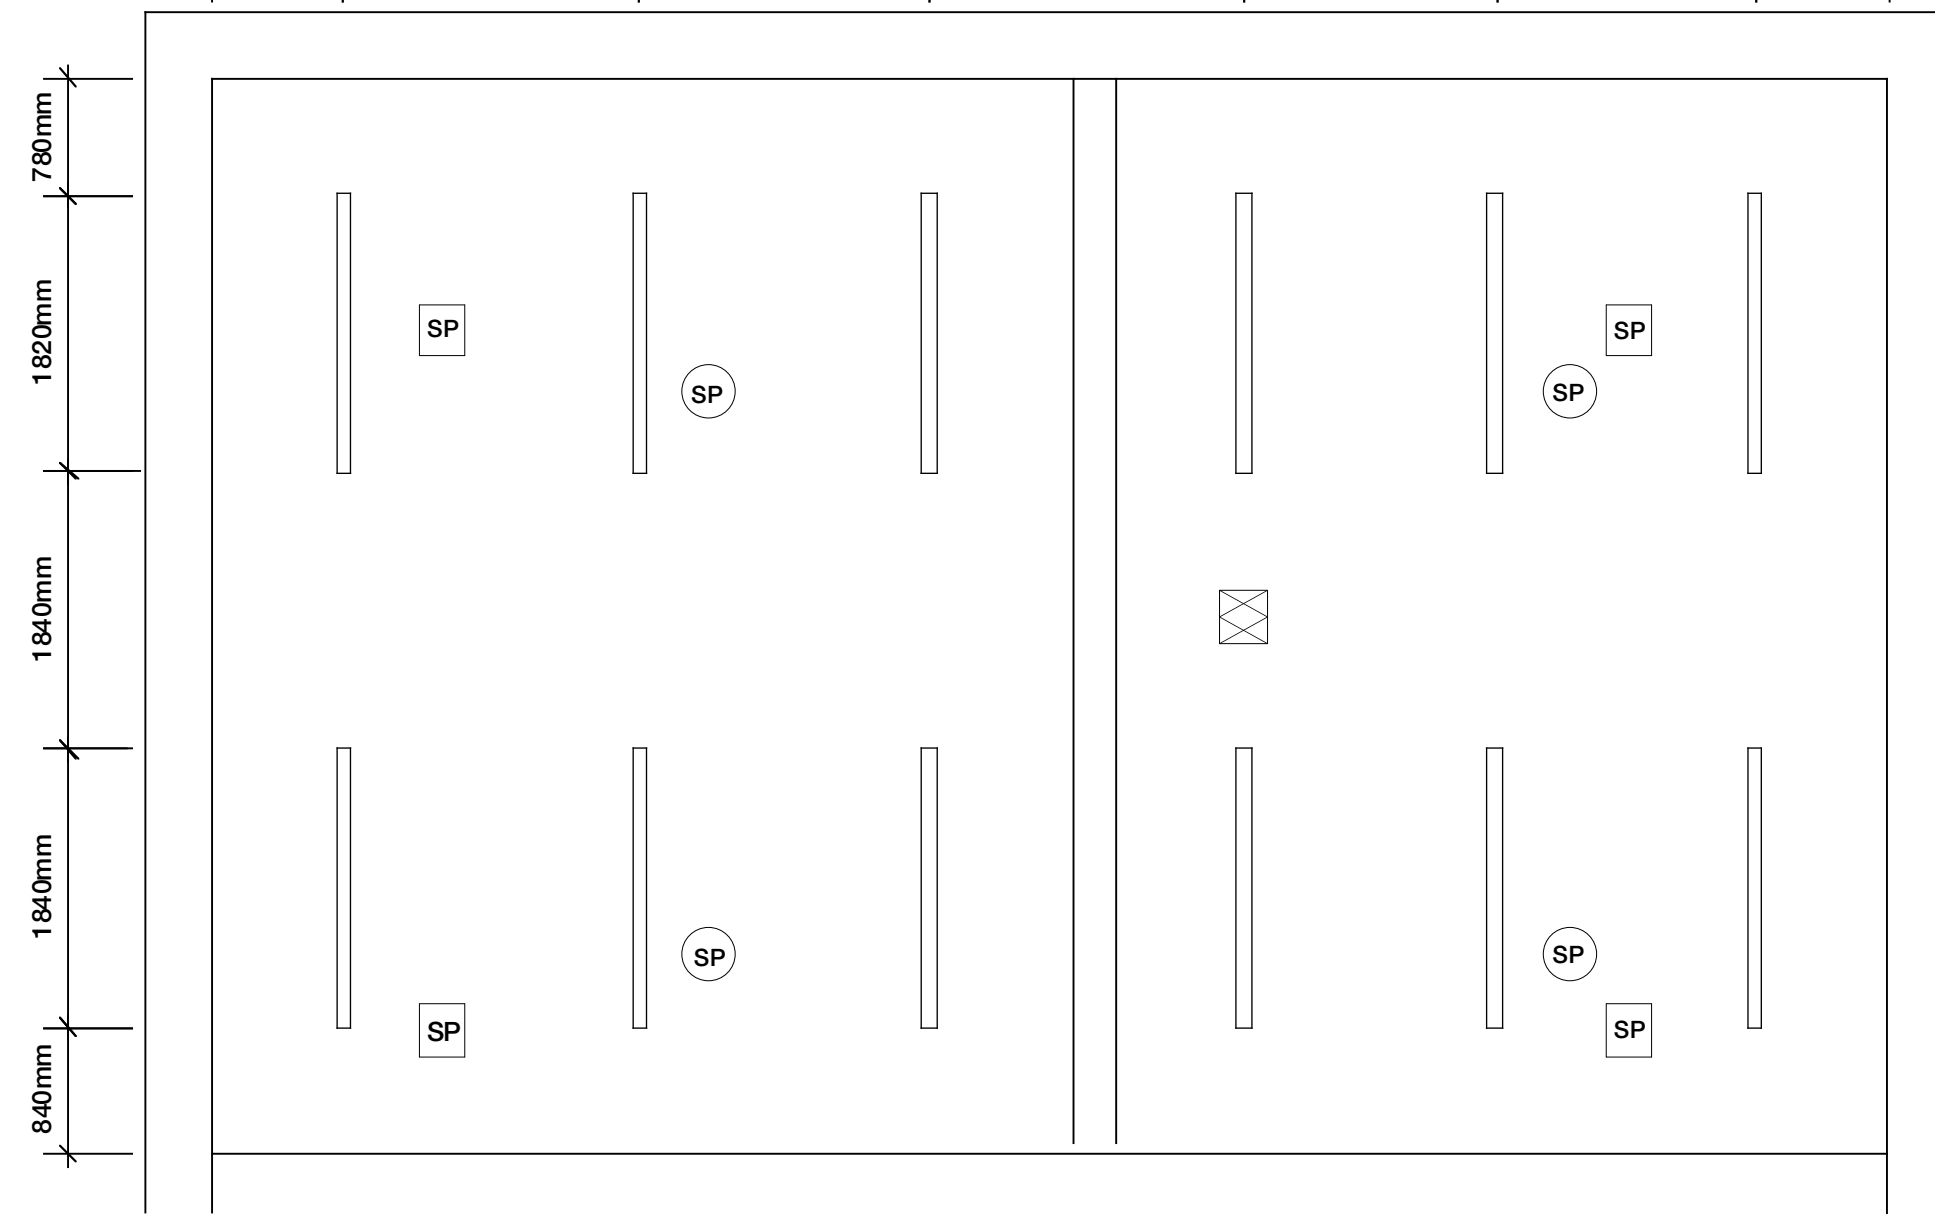



PLAN

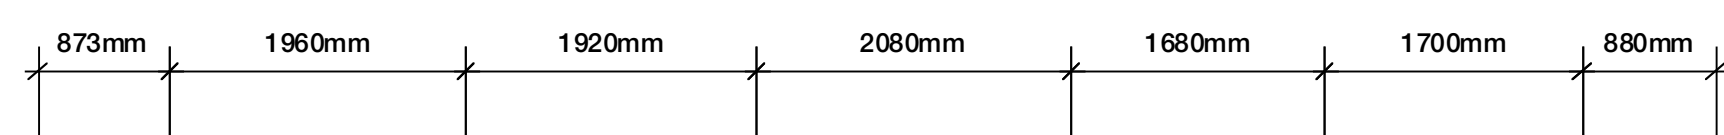


REFLECTED CEILING PLAN (RCP)

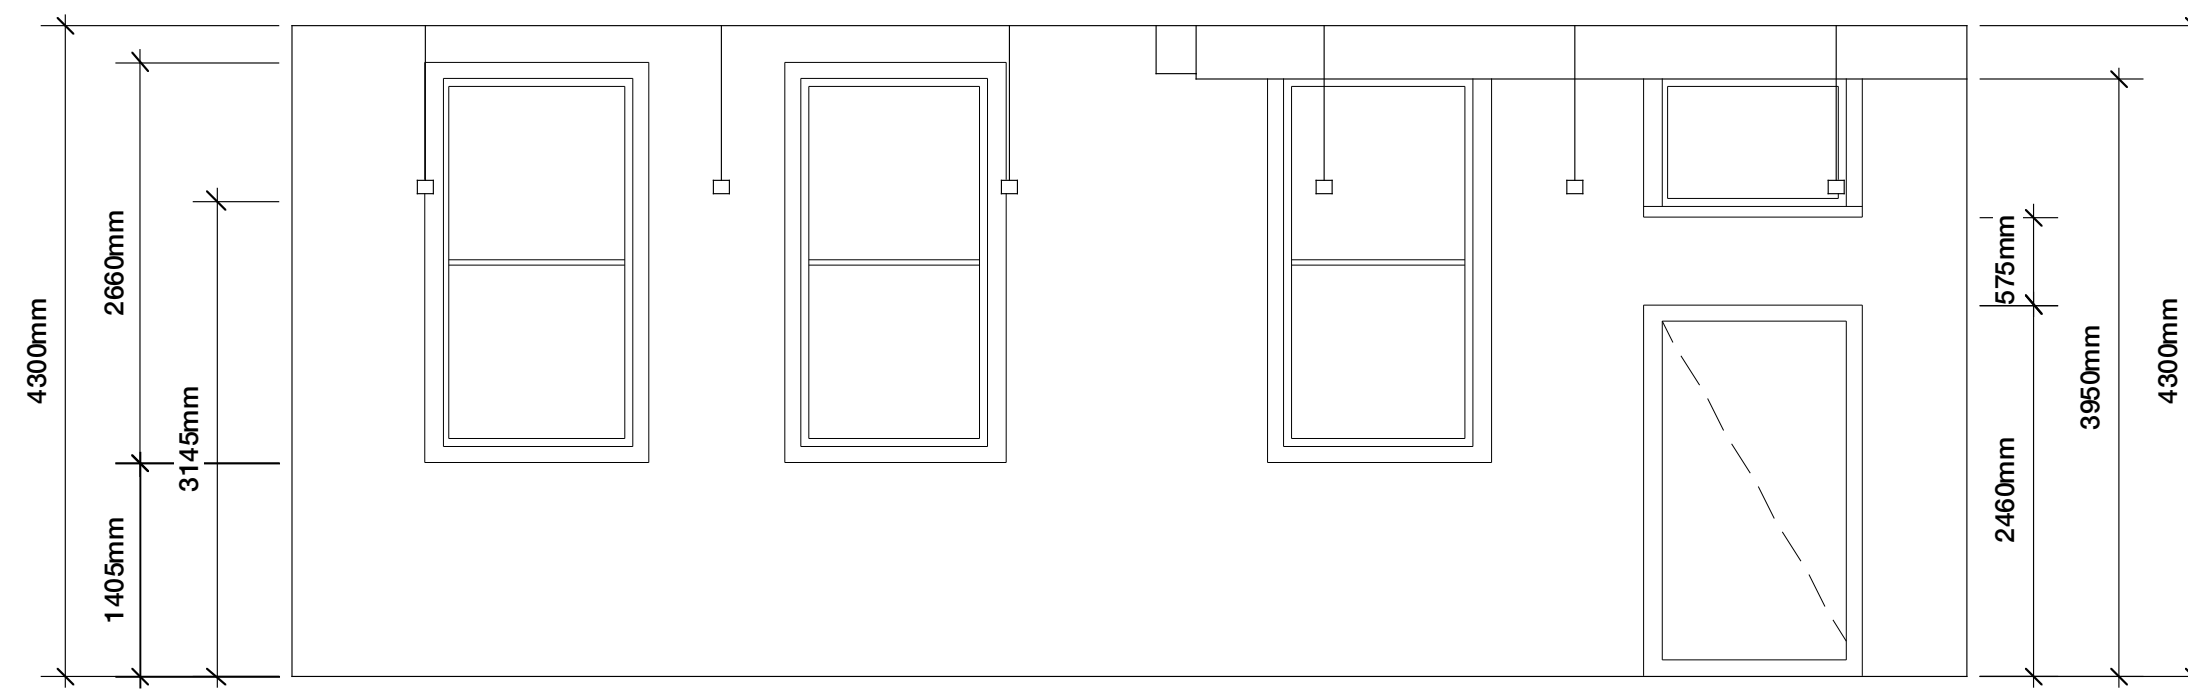


ELEVATION A

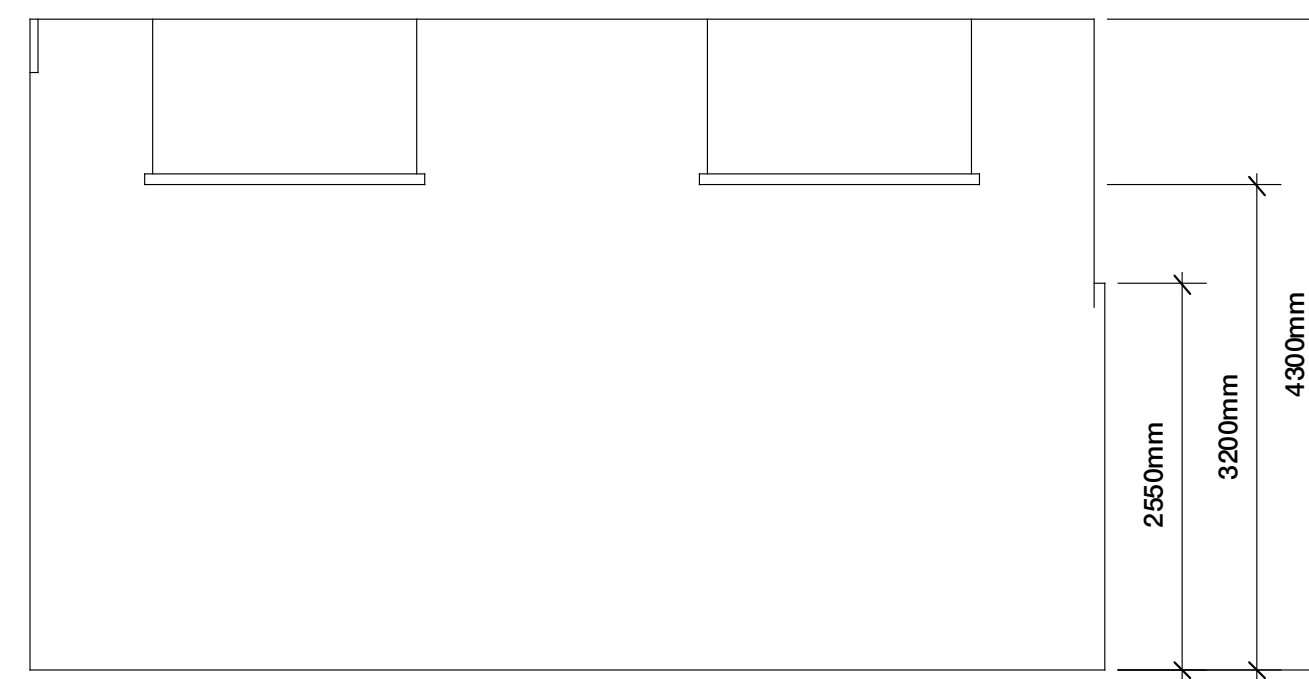

ELEVATION B

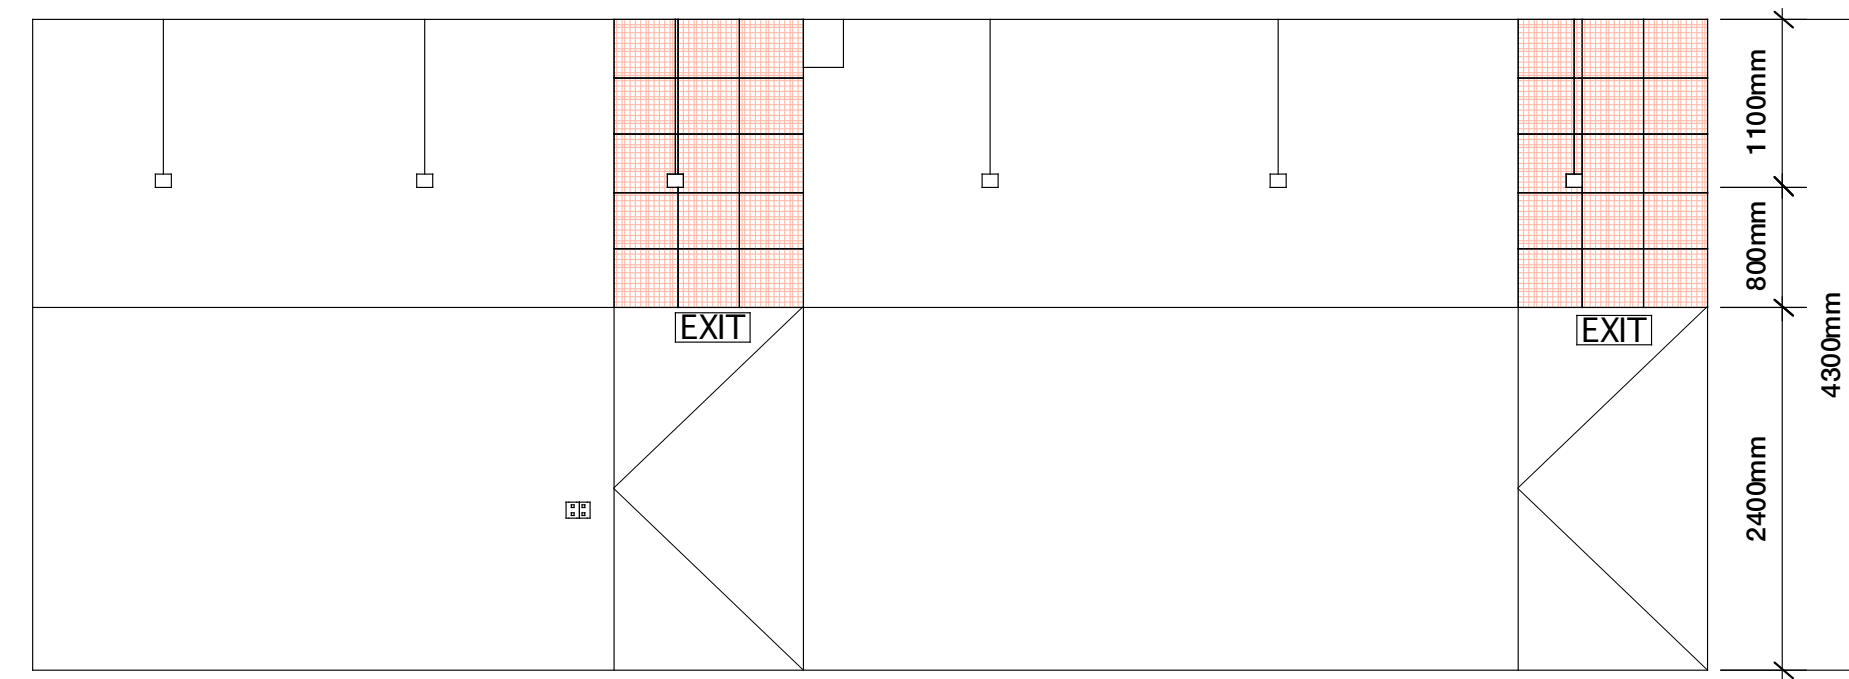

ELEVATION C

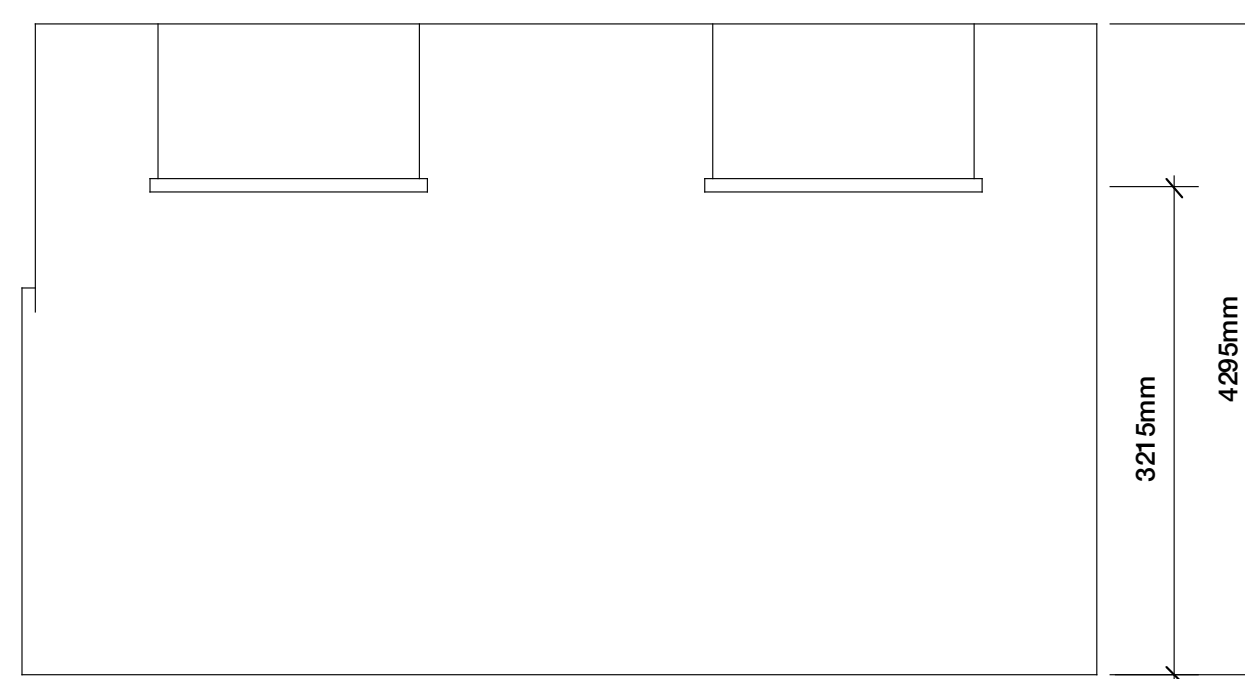

ELEVATION C

LEGEND

- HOUSE LIGHT
- HOUSE LIGHT CONTROL
- DATA OUTLET RJ45
- DOUBLE GPO
- SPEAKER
- SPEAKER
- DATA POINT/PROJECTION

DISCLAIMER

WHILST EVERY EFFORT HAS BEEN MADE TO ENSURE THE ACCURACY OF THIS DRAWING BLUEBOTTLE 3 PTY LTD OFFERS NO WARRANTY. PLEASE CHECK ALL DIMENSIONS ON SITE PRIOR TO COMMENCING ANY WORKS. WRITTEN DIMENSIONS HAVE PRECEDENCE OVER SCALED MEASUREMENTS. IF YOU ARE UNSURE PLEASE CHECK FIRST.



BLUEBOTTLE 3 PTY LTD
 6/24 EASTERN RD SOUTH MELBOURNE
 PHONE 61 3 9645 9949
 FAX 61 3 9645 9982
 EMAIL MAIL@BB3.NET.AU
 PROFESSIONAL IN CONFIDENCE BLUEBOTTLE 3 PTY LTD
 METROPOLITAN MEAT MARKET
 CNR COURTNEY & BLACKWOOD ST, NTH MELB.
 CONFERENCE ROOM, PLAN, RCP & ELEVATIONS
 SCALE 1:50 @ A1
 DATE 24/09/05
 DRAWN DS
 CHECK
 DWG NO 03/203-05
 REASON FOR ISSUE FOR INFORMATION ONLY
 REVISION -

